

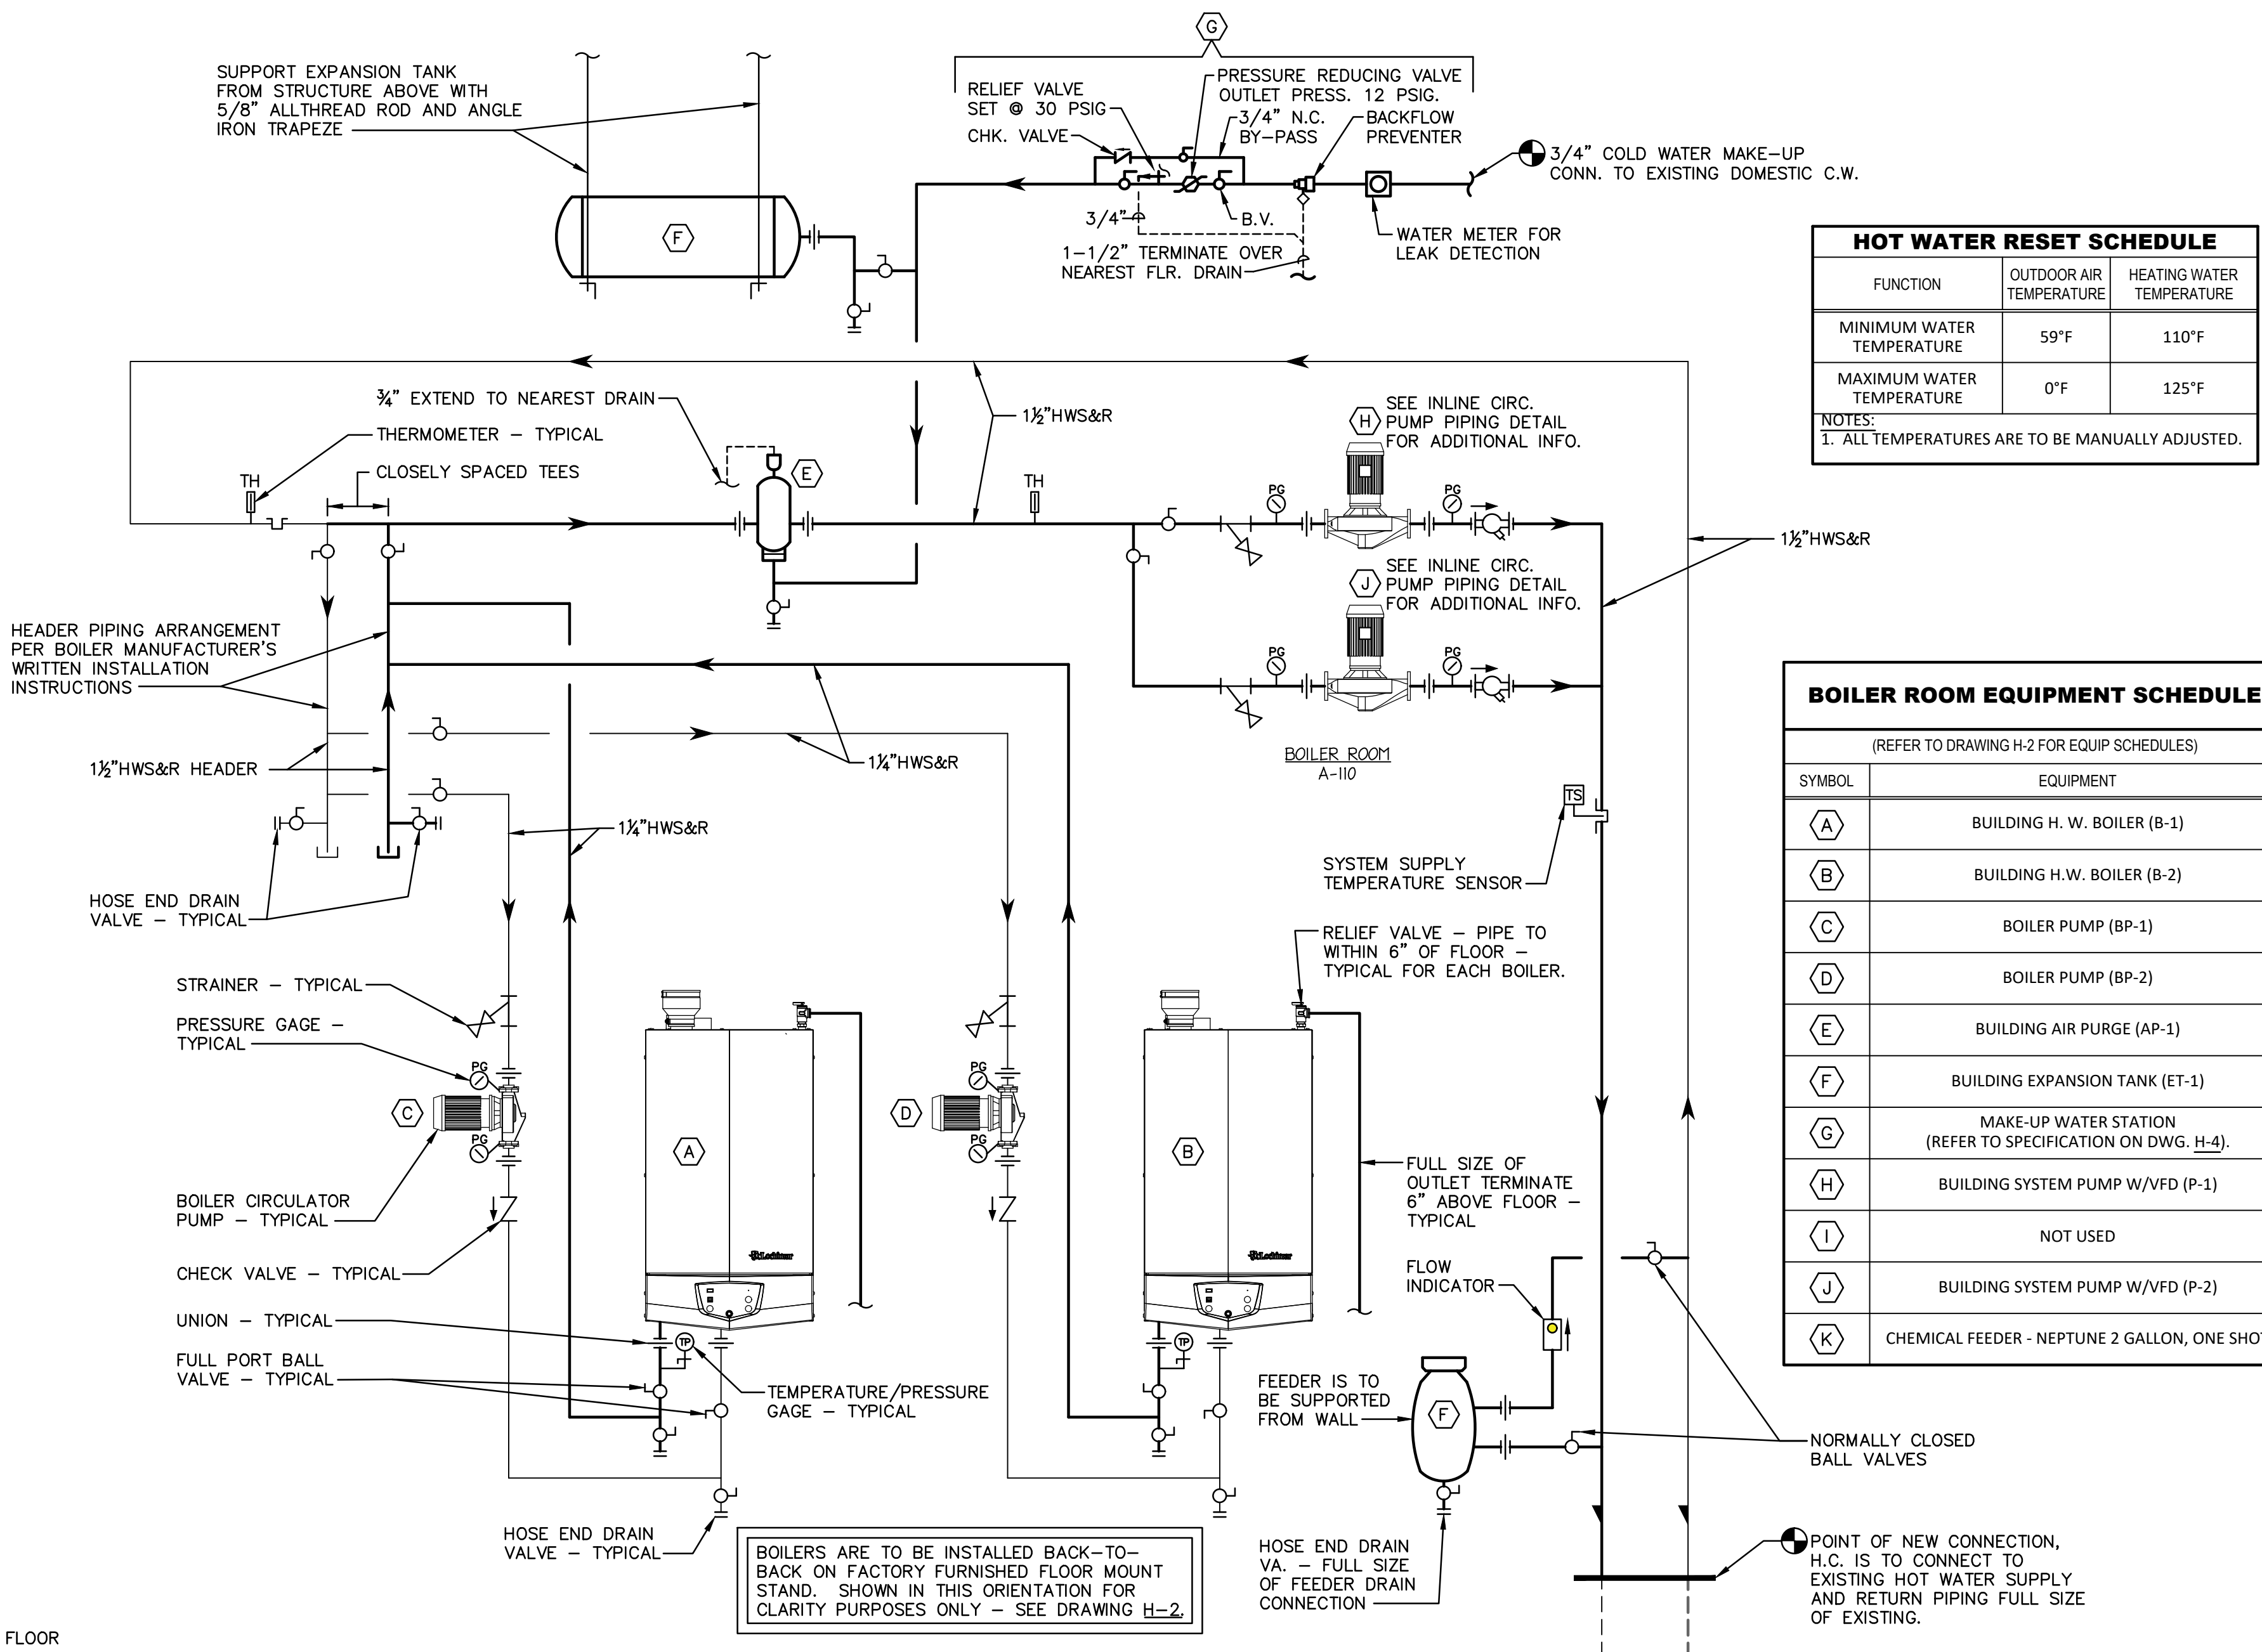
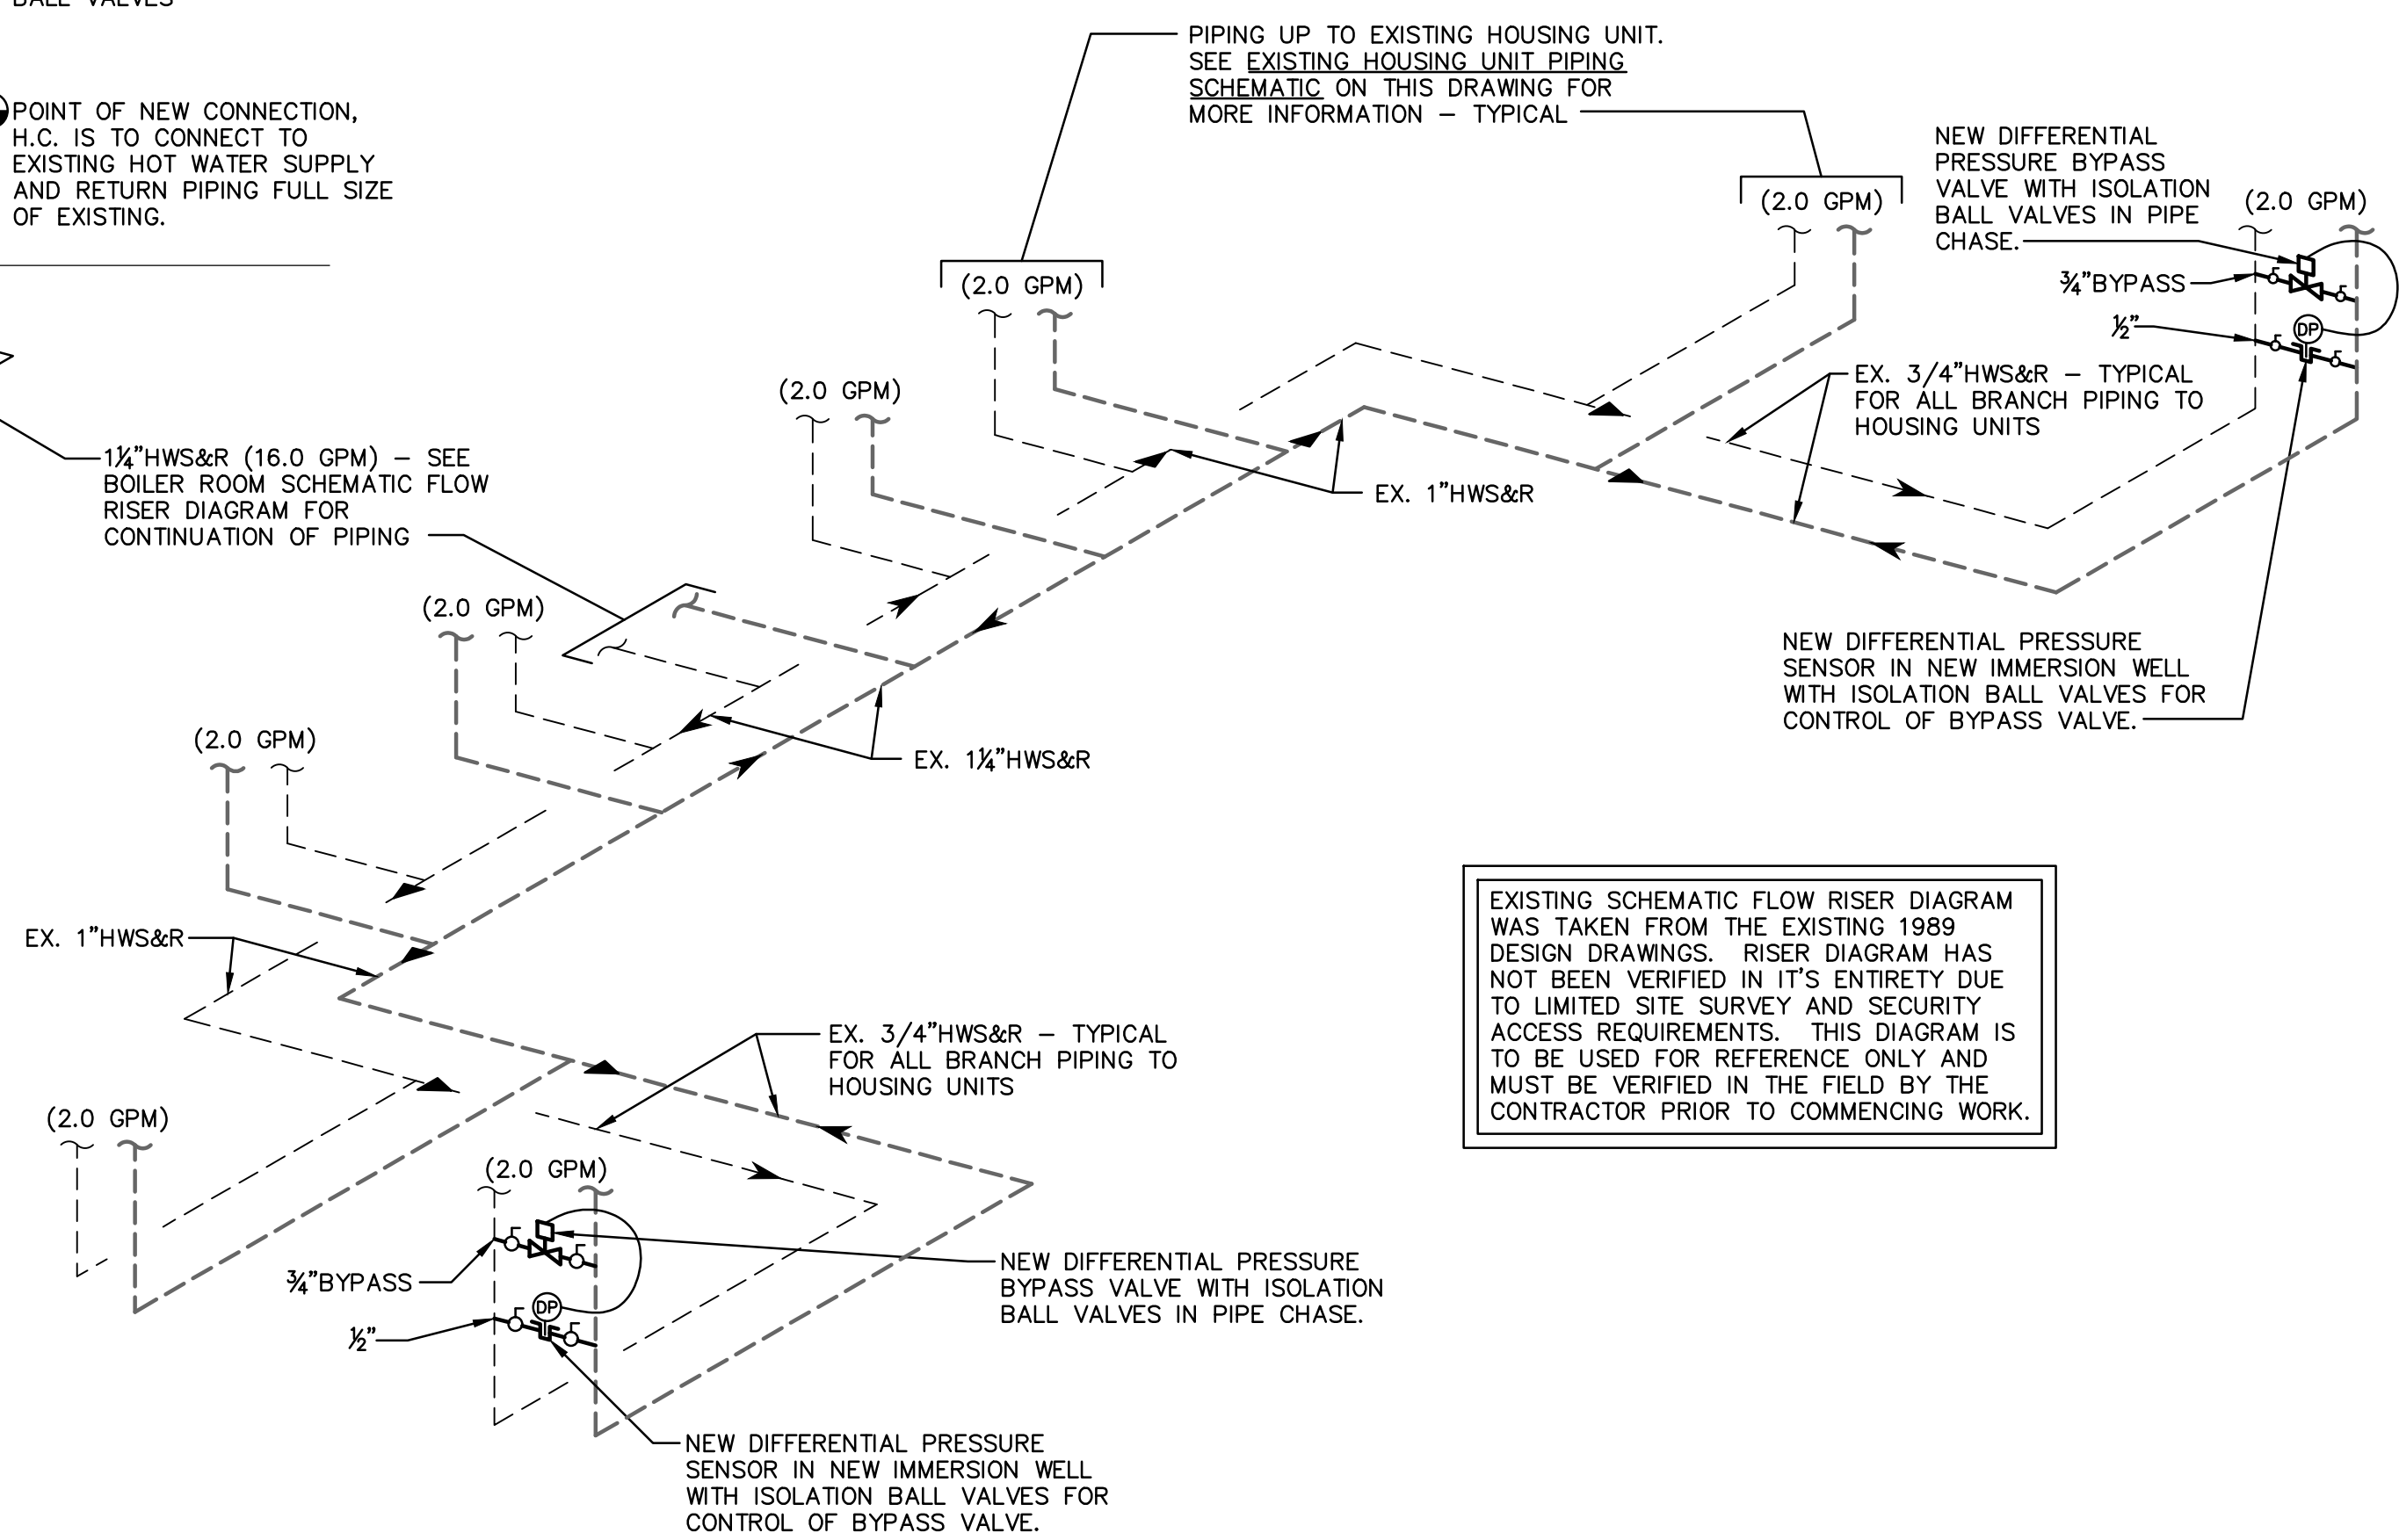


**BOILER ROOM A-110
BOILER REPLACEMENT AND SYSTEM UPGRADES**
FOR
CLINTON COUNTY CORRECTIONAL FACILITY
58 PINE MOUNTAIN ROAD, McELHATTAN, PA 17748

HVAC DETAILS

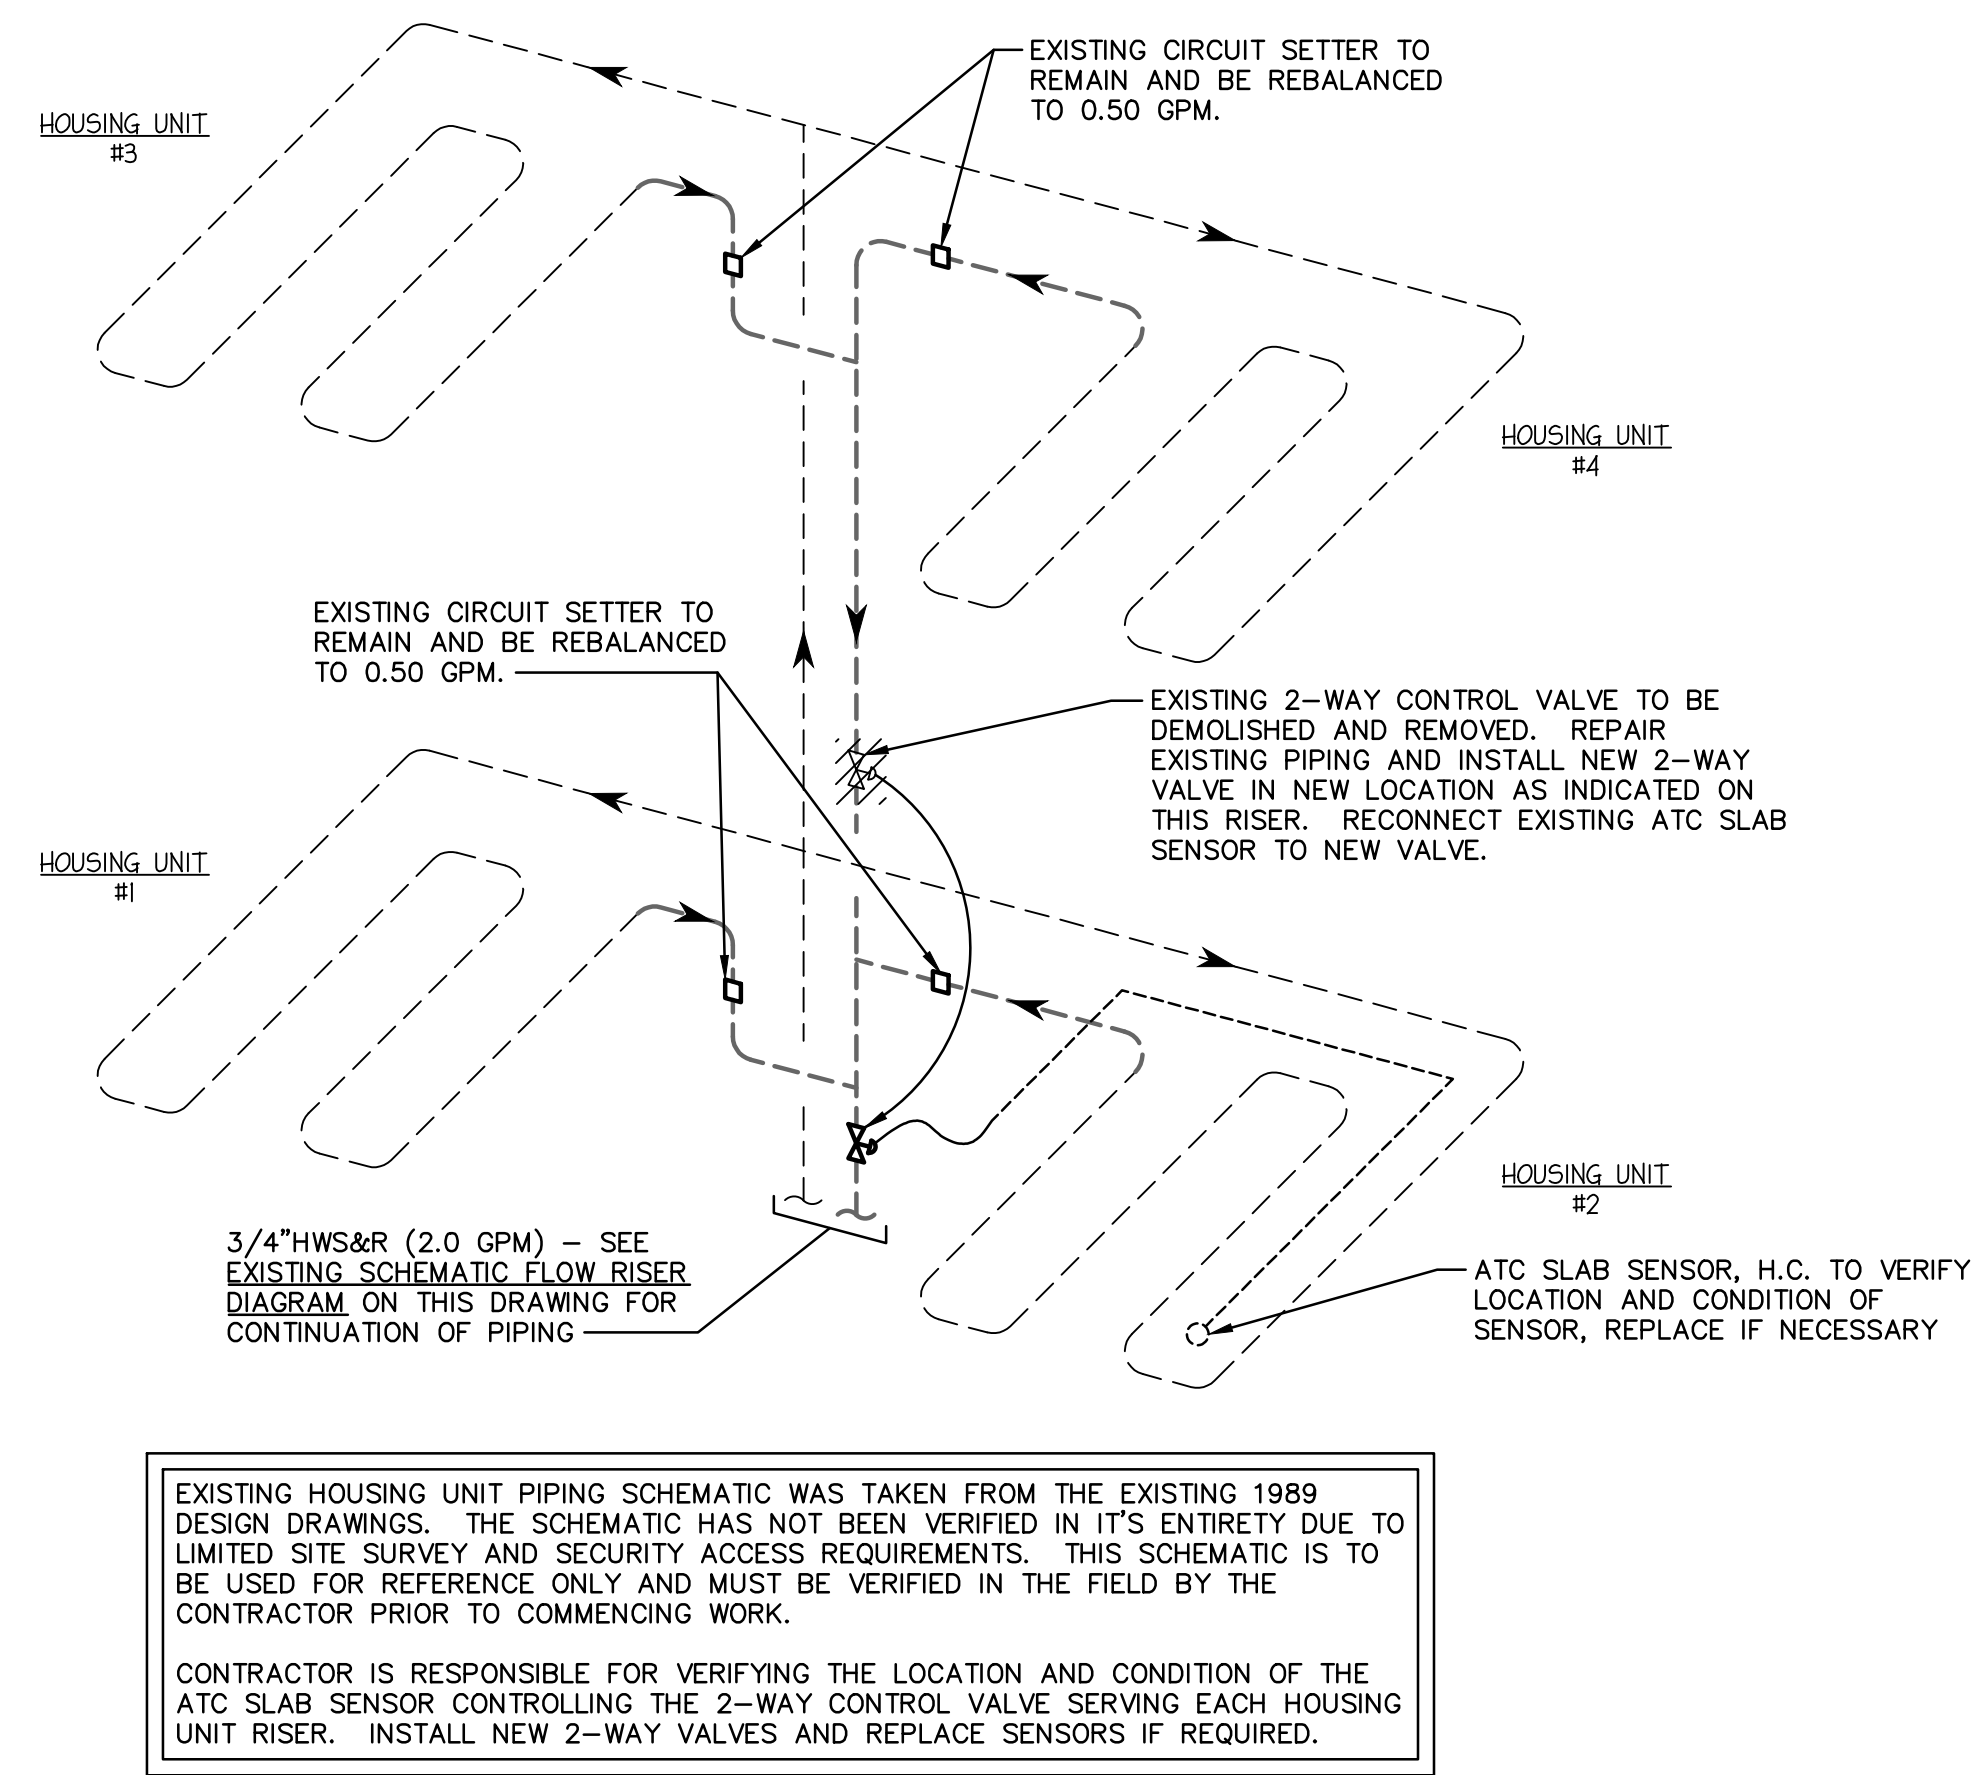

BOILER ROOM SCHEMATIC FLOW DIAGRAM
NOT TO SCALE

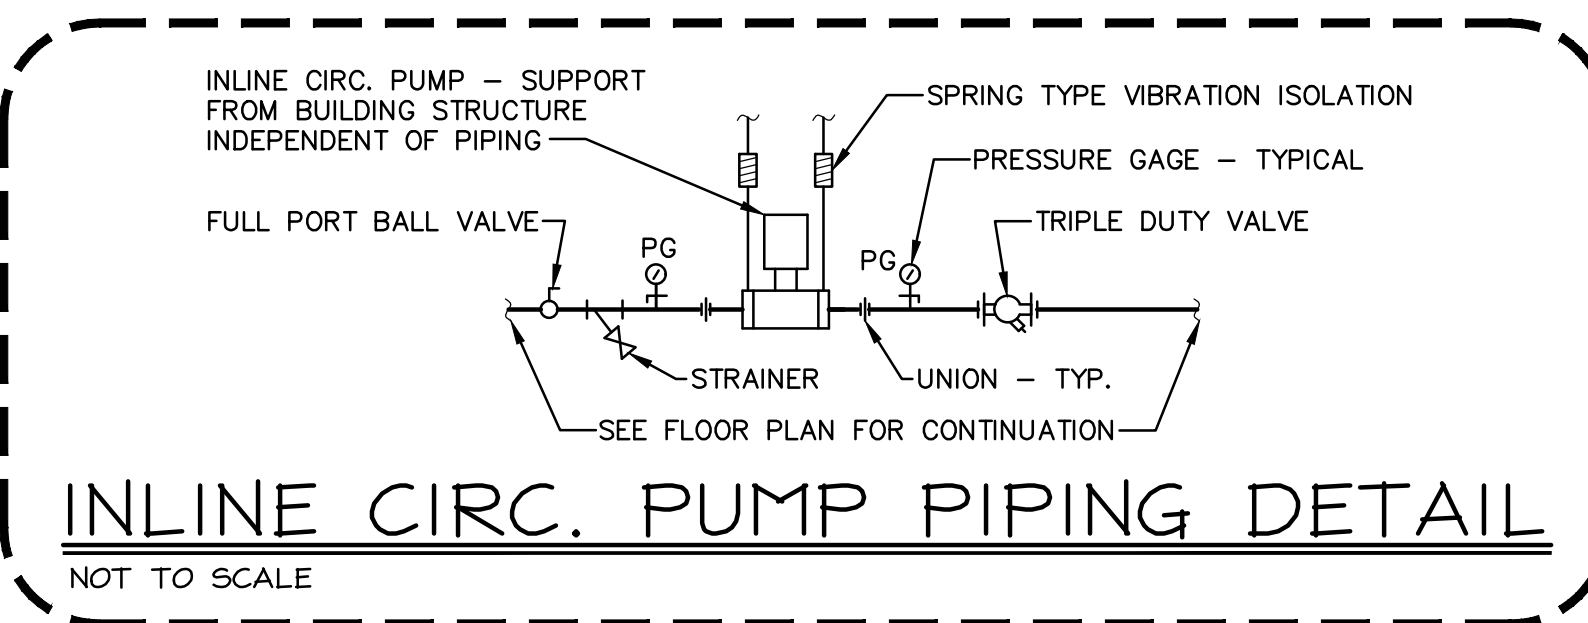

September 27, 2019 - 1:42pm \\EastHills\Server\Company Public\Projects\2019\19139 - Clinton County Correctional Facility Boiler\Drawings\19139 - H3.dwg

REVISIONS		
MARK	BY	DATE

DATE: 09-27-2019	DRAWING NO. H-3
DRAWN BY: K.E.K.	
CHECKED BY: C.G.A.	
PROJECT NO. EHEA 19139	

**East Hills
Engineering
Associates**
A LIMITED LIABILITY COMPANY

BRETT N. YONISH, P.E.
CHRISTOPHER G. ALBRIGHT, P.E.

541 MAIN STREET
WINDBER, PA 15963
(814) 467-6877